

**9층, 11층 전등설비 평면도**  
축척 : 1/140 (1/80)

△	
△	
△	
△	
△	

DRAWN BY  
CHECKED BY  
APPROVED BY



DRAWING NAME  
9층, 11층 전등설비 평면도

SCALE  
1/80

DATE  
2021.06

PROJECT NO.

DRAWING NO.  
P-001

SHEET NO.  
003


PROJECT TITLE




소사캠퍼스 라운지

7층 4단락카 : 38EA

층 : 152칸

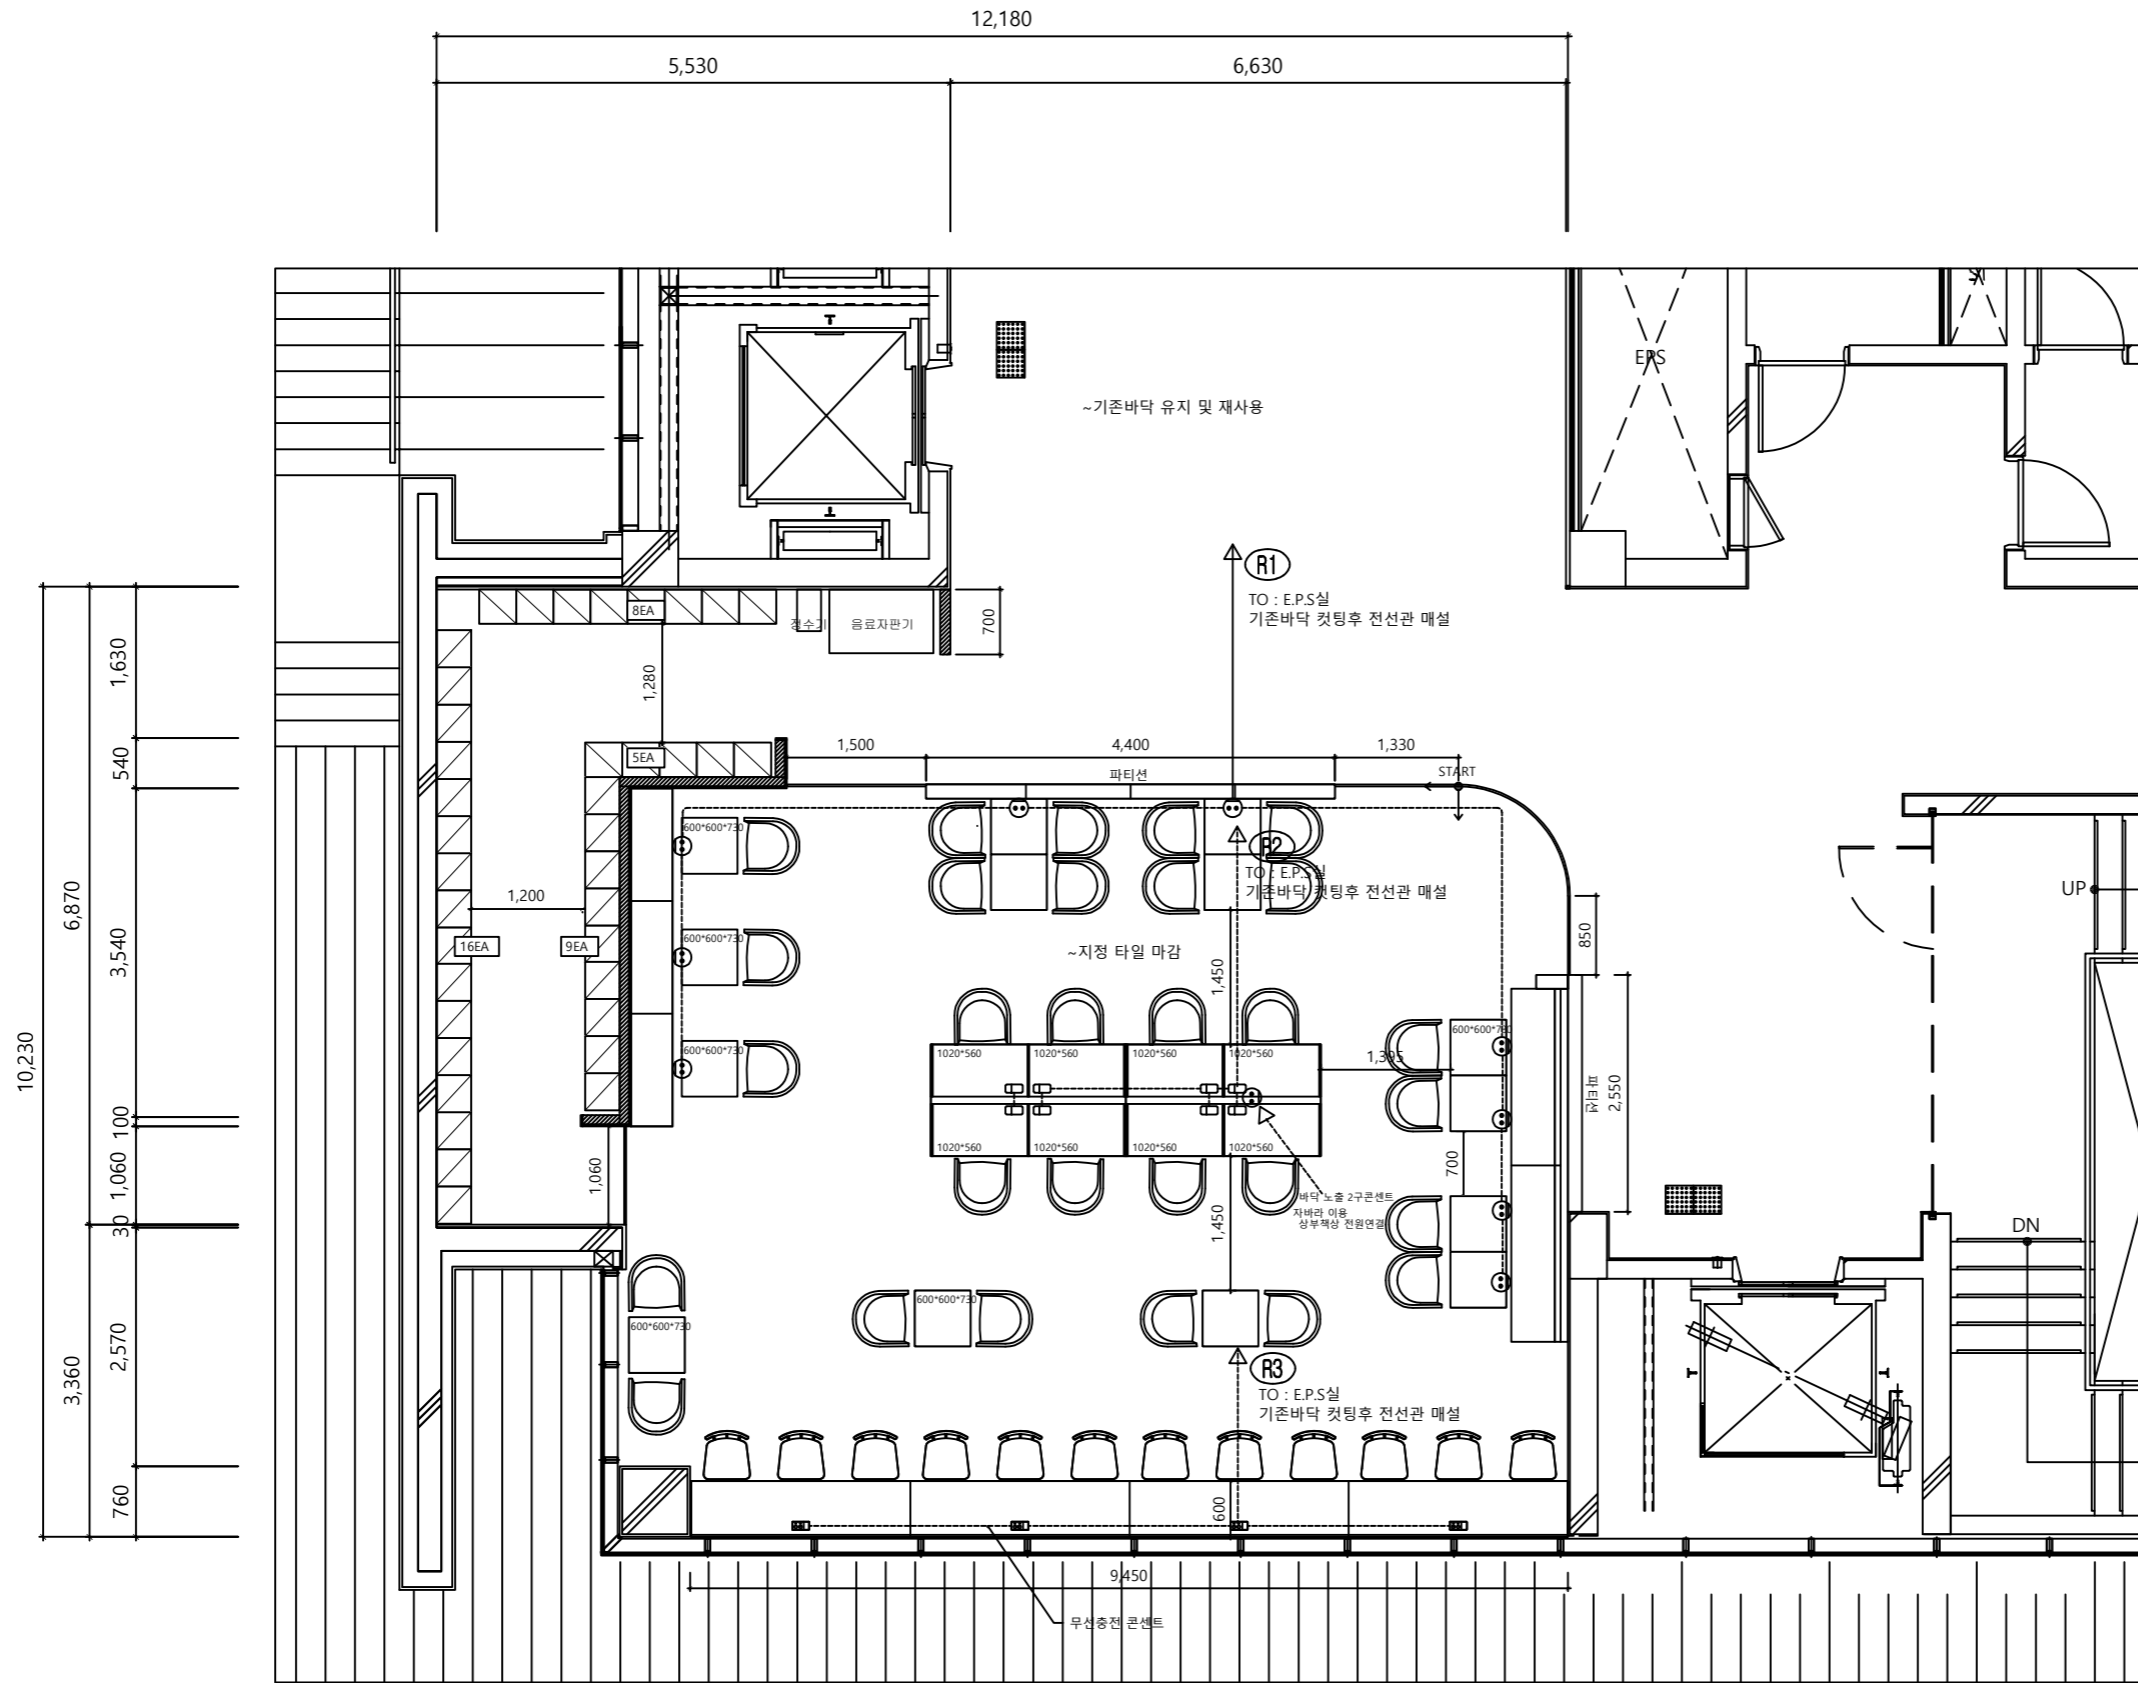

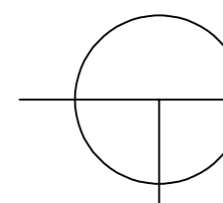
**9층, 11층 전열설비 평면도**  
 축척 : 1/140 (1/80)


DRAWN BY  
 CHECKED BY  
 APPROVED BY



DRAWING NAME  
 9층, 11층 전열설비 평면도


SCALE  
 1/80

DATE  
 2021.06

PROJECT NO.

DRAWING NO.  
 P-001

SHEET NO.  
 003

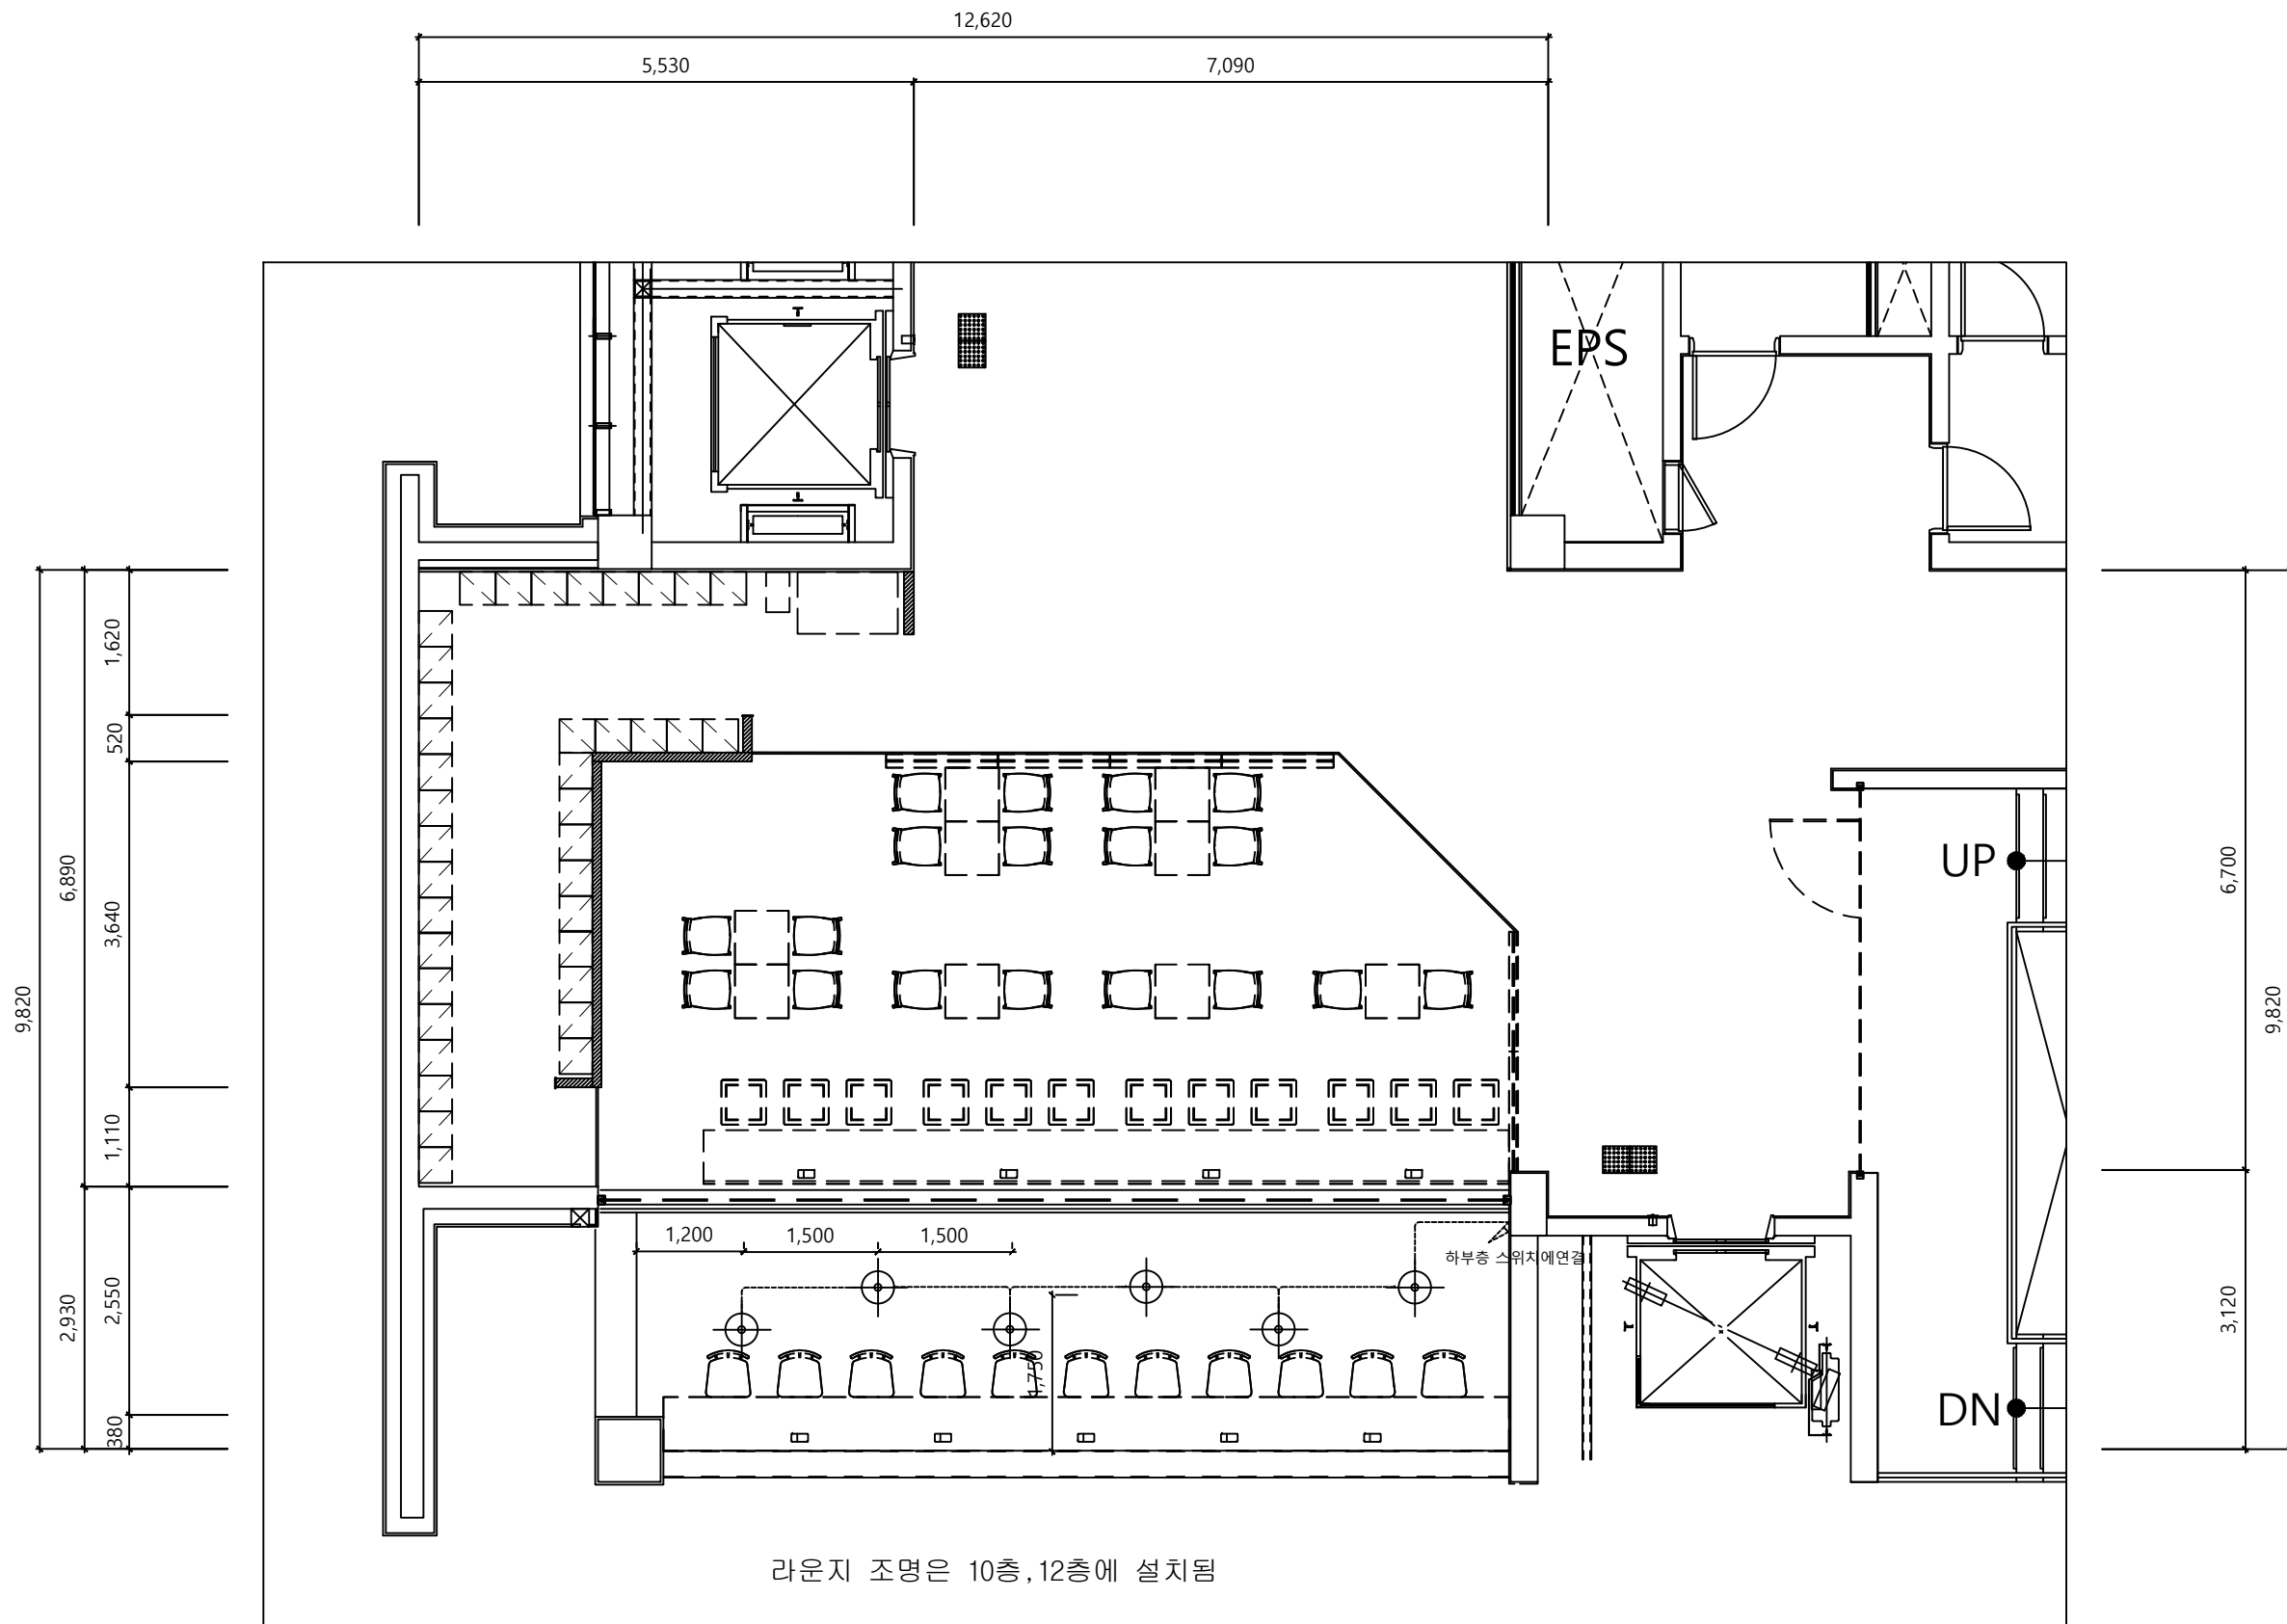

# 10층 전등설비 평면도

축척 : 1/140 (1/80)

■ LEGEND

SYM	NAME	EA
⊕	볼 펜던트 Ø300	6


DRAWN BY  
 CHECKED BY  
 APPROVED BY



DRAWING NAME  
10층 전등설비 평면도

SCALE  
1/80


DATE  
2021.06

PROJECT NO.

DRAWING NO.  
P-010

SHEET NO.  
012

1 8F CEILING PLAN  
scale 1:80

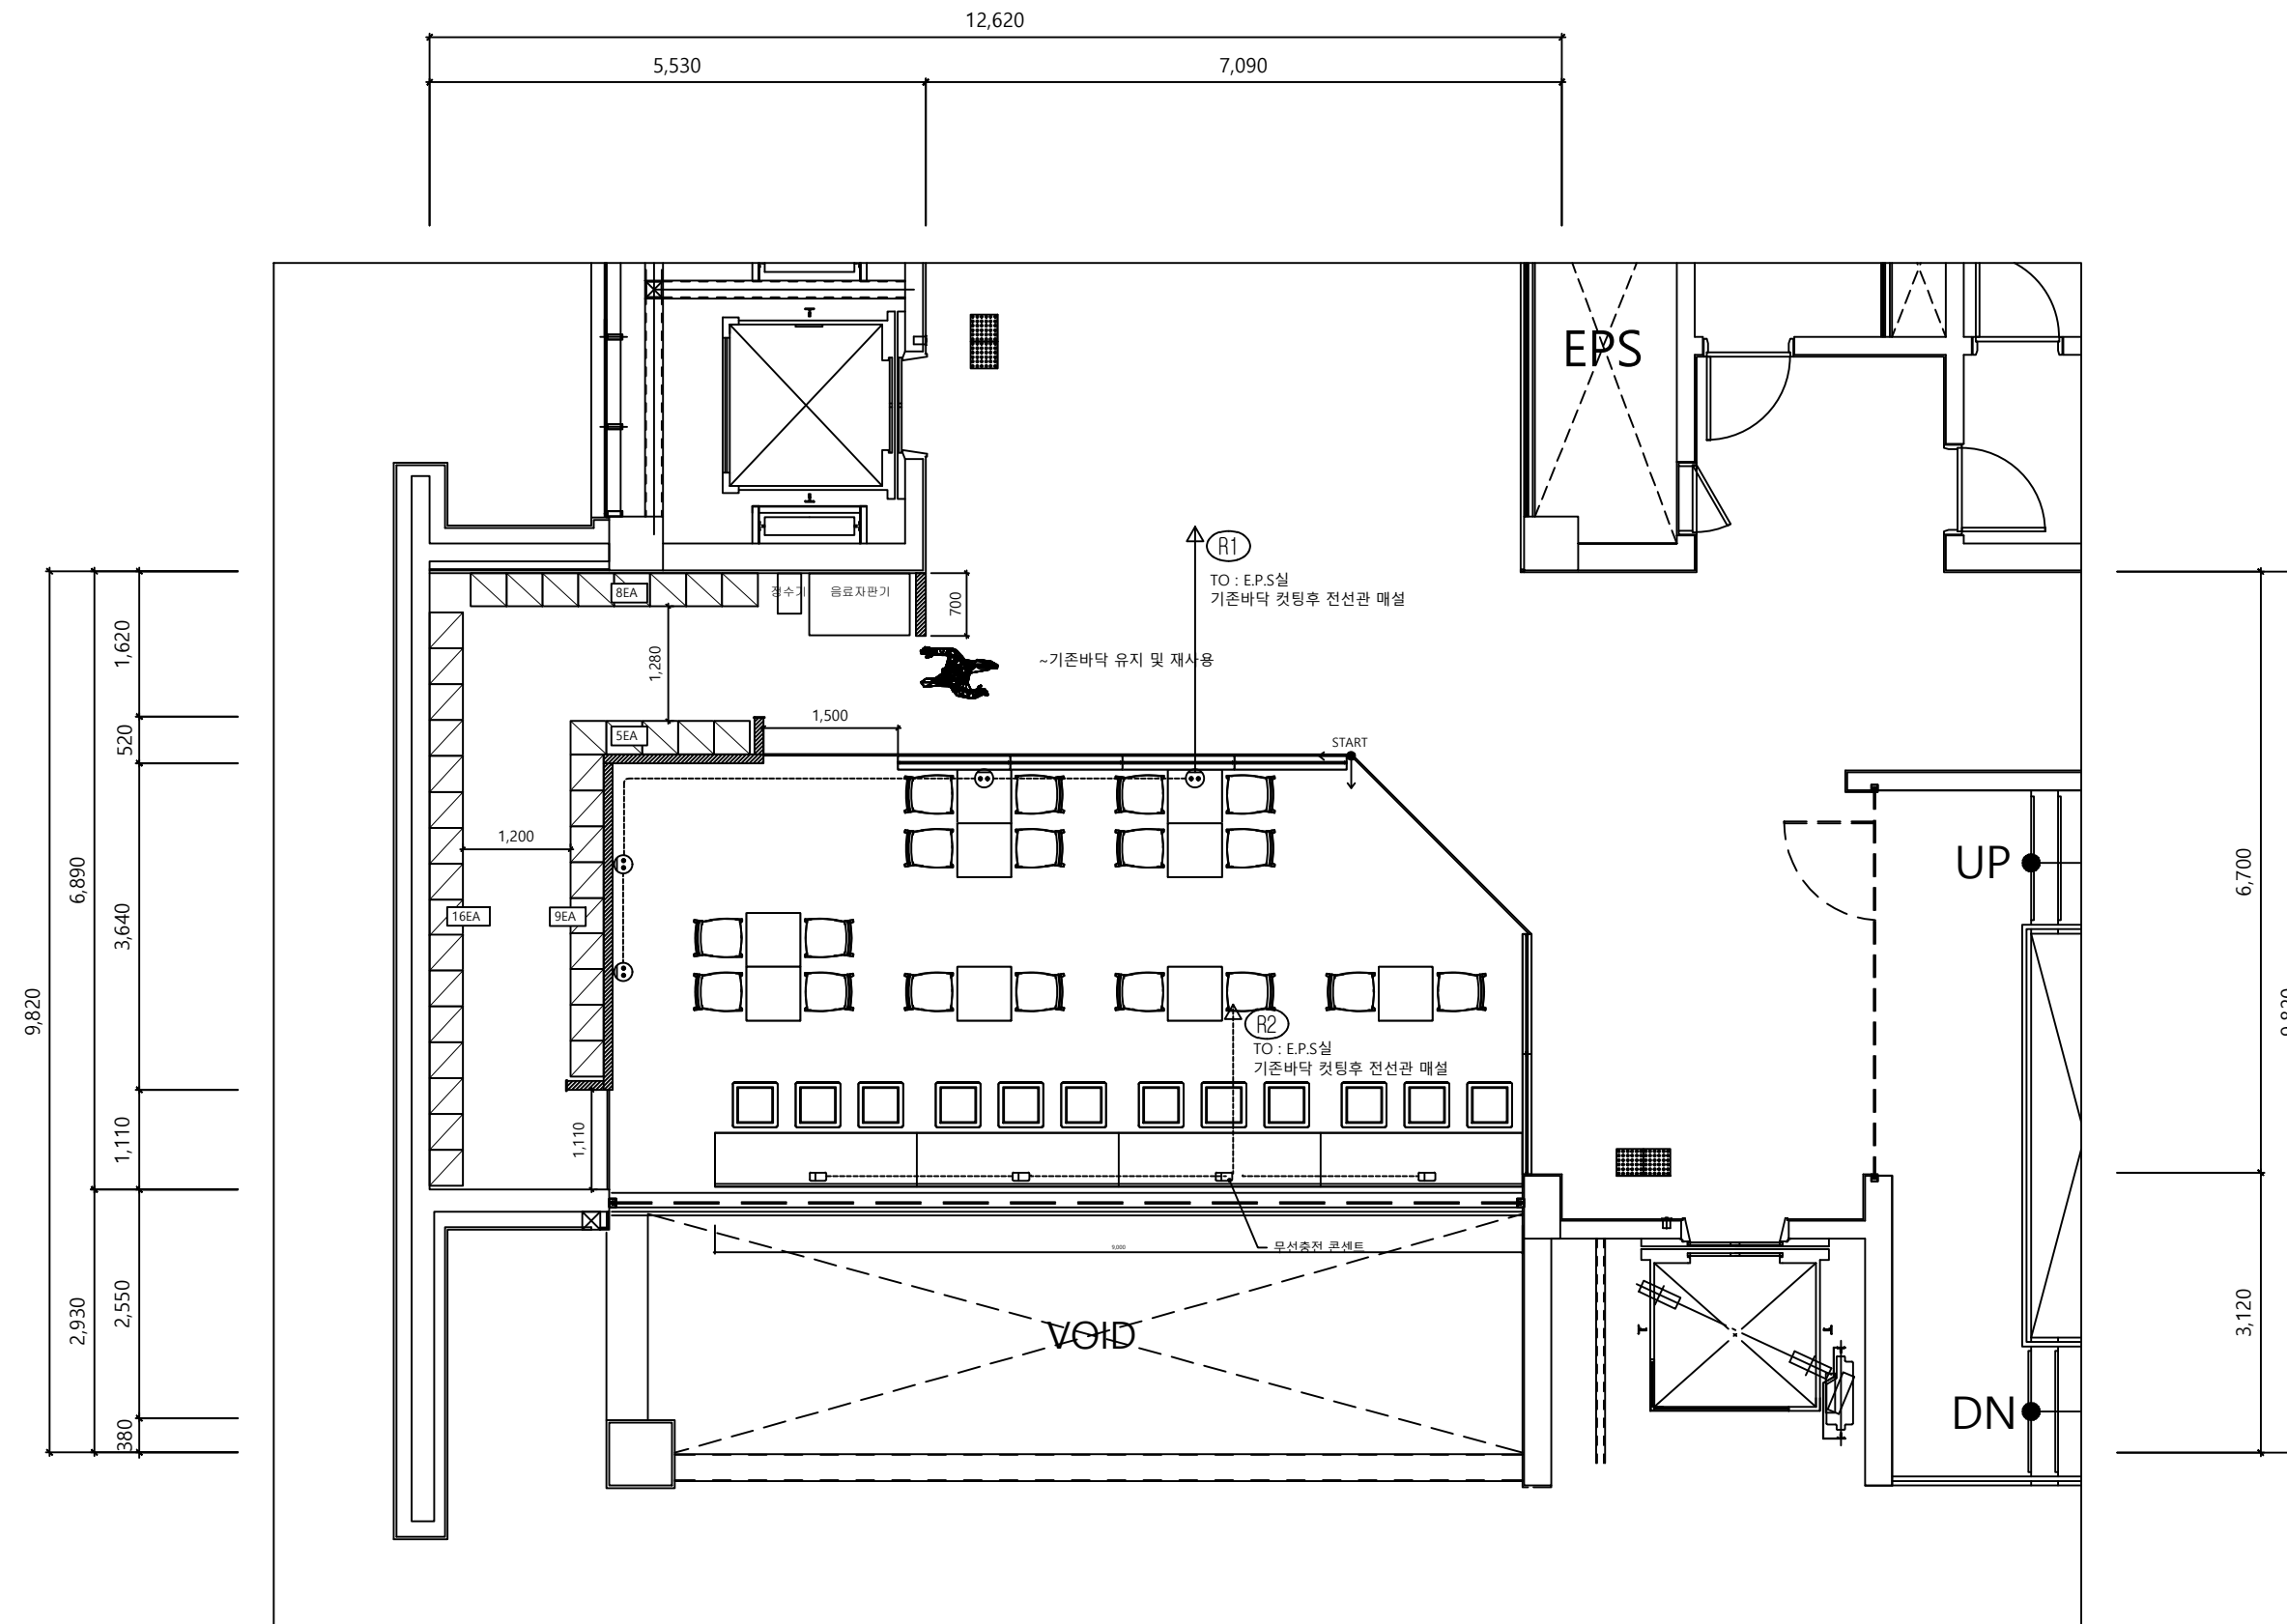


DRAWN BY  
CHECKED BY  
APPROVED BY



DRAWING NAME	10층 전열설비 평면도
SCALE	
DATE	2021.06
PROJECT NO.	
DRAWING NO.	
SHEET NO.	

# 10층 전열설비 평면도

축척 : 1/140 (1/80)

1 8F FLOOR PLAN  
scale 1:80

